



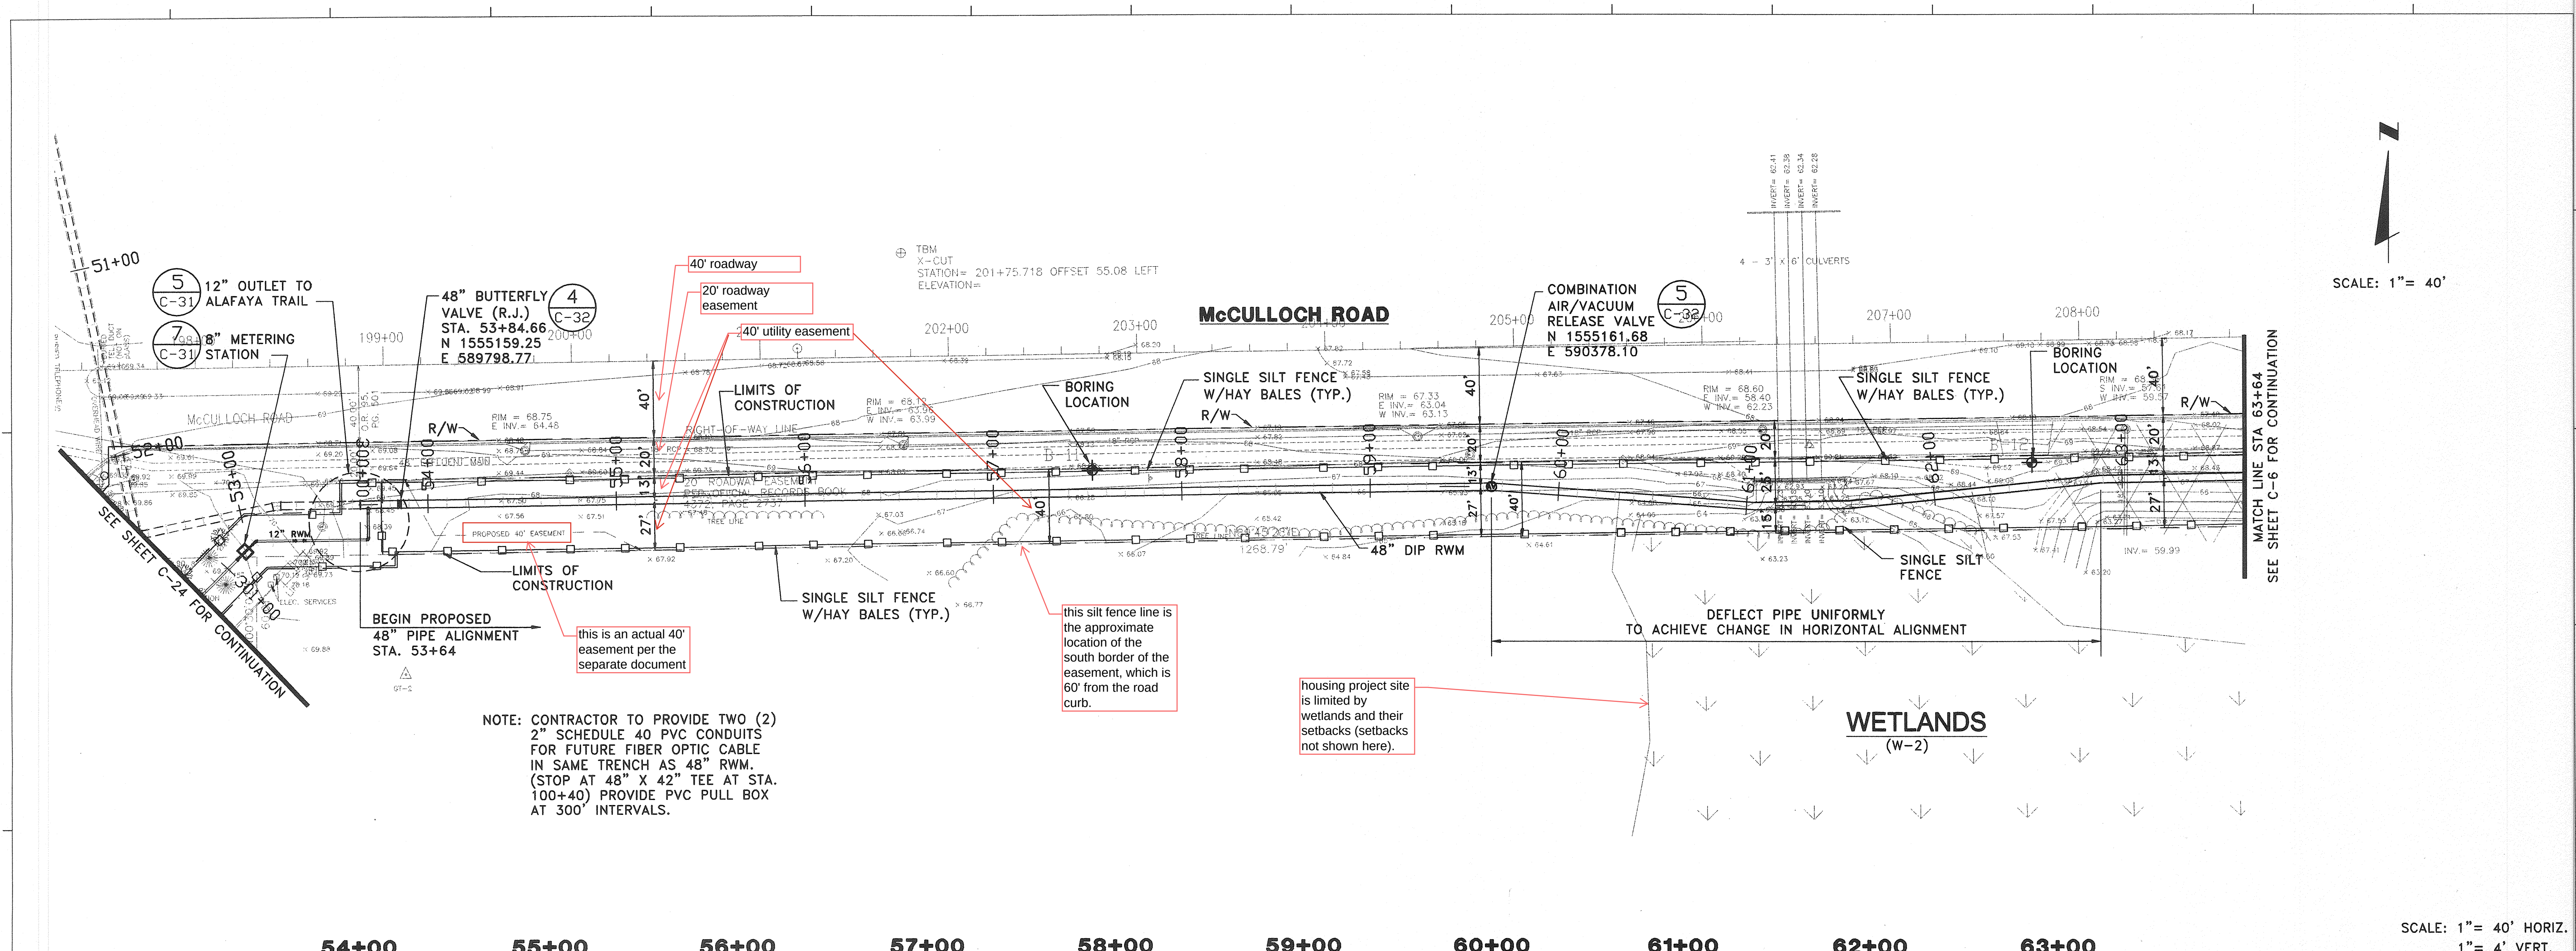

SCALE: 1" = 40'

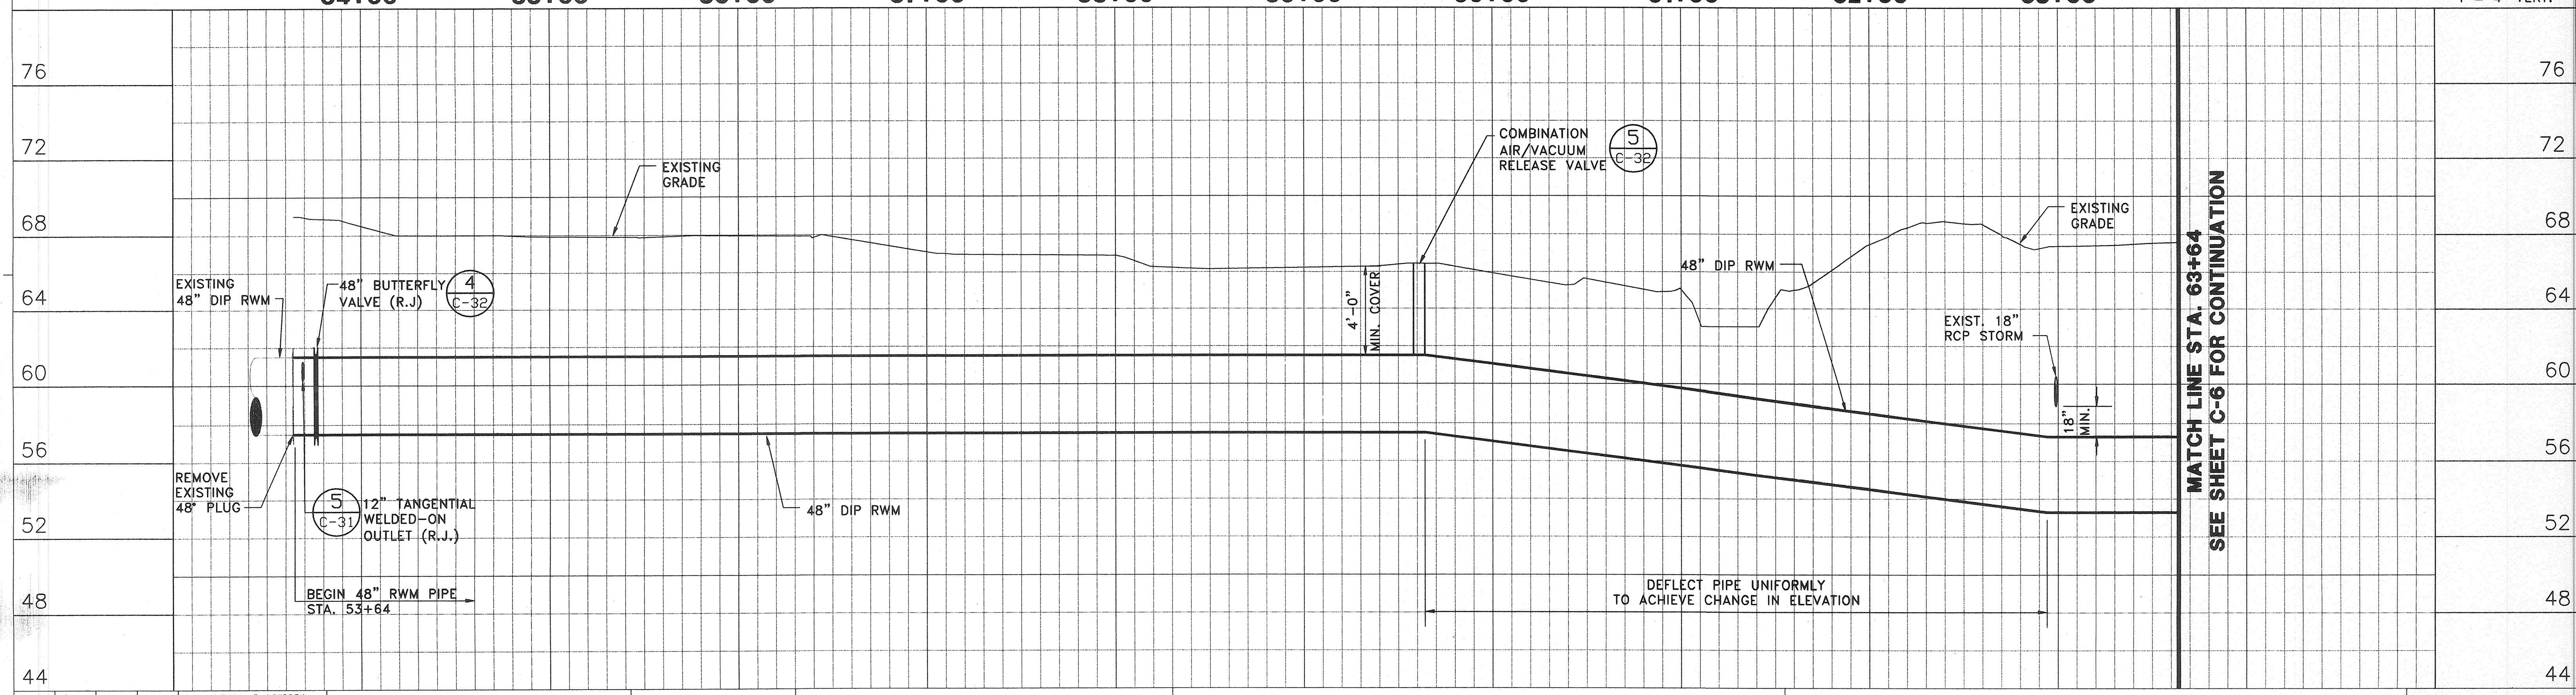

SCALE: 1" = 40' HORIZ.
1" = 4' VERT.

Name: WILLIAM R. WHIDDEN Florida P.E. No.: 24195 Address: PBS&J 482 S. Keller Road Orlando, FL 32810-6101				DESIGNED BY: WRW/PEH DRAWN BY: GG SHEET CHK'D BY: _____ CROSS CHK'D BY: _____ APPROVED BY: _____ DATE: 11/21/2003				PBS&J 482 South Keller Road ORLANDO, FL 32810-6101 TEL: (407) 547-1775 FAX: (407) 547-0624 WWW.PBS&J.COM CONSTRUCTION PLANS PREPARED FOR: CAMP DRESSER & MOORE, INC. 2301 ATLANTIC CENTER PARKWAY SUITE 300 ATLANTIC, FL 32720 UNDER THE EASTERN REGIONAL RECLAIMED WATER DISTRIBUTION SYSTEM CONTRACT				CITY OF ORLANDO EASTERN REGIONAL RECLAIMED WATER DISTRIBUTION SYSTEM PHASE II TRANSMISSION MAIN				McCULLOCH ROAD PLAN AND PROFILE STA. 53+64 TO STA. 63+64				PROJECT NO. FILE NAME: UCF_434_C-5.DWG SHEET NO. C-5	
REV.	DATE	DRWN	CHKD	Signature		Date		REMARKS													